



UNKNOWN GRADIENT/FALL.
MAY REQUIRE ADDITIONAL
CONDENSATE TRAPS.

LEACHATE SOAK TRENCH.
(INWARD LIMIT OF MSE WALL)


REV	DESCRIPTION	BY	CHKD	APP	DATE
E					
D	ADDED AIR/LEACHATE TO KOP. REVISED 315MM HEADER.	ZB	RC	RC	27.08.2020
C	REVISED 315MM HEADER TIE IN LOCATIONS	ZB	RC	RC	26.08.2020
B	ADDED JTRAPS TO SUMPS 9 AND 10.	ZB	RC	RC	26.08.2020
A	GCS INSTALLATION	ZB	RC	RC	25.08.2020
REV	DESCRIPTION	BY	CHKD	APP	DATE

REVISION HISTORY




PROJECT: ERSKINE PARK LANDFILL GAS PROJECT
DRAWING TITLE: GAS COLLECTION SYSTEM INSTALLATION


DRAWING No:	019-DN-007		
DRAWING TYPE:	DESIGN		
DRAWN:	ZB	CKD:	RC
DATE:	27.08.2020	APP:	RC
DESIGNED:	RC	APP DATE:	27.08.2020
SCALE:	1:1000	SHEET:	1 of 1
REV:	D	SIZE:	A1

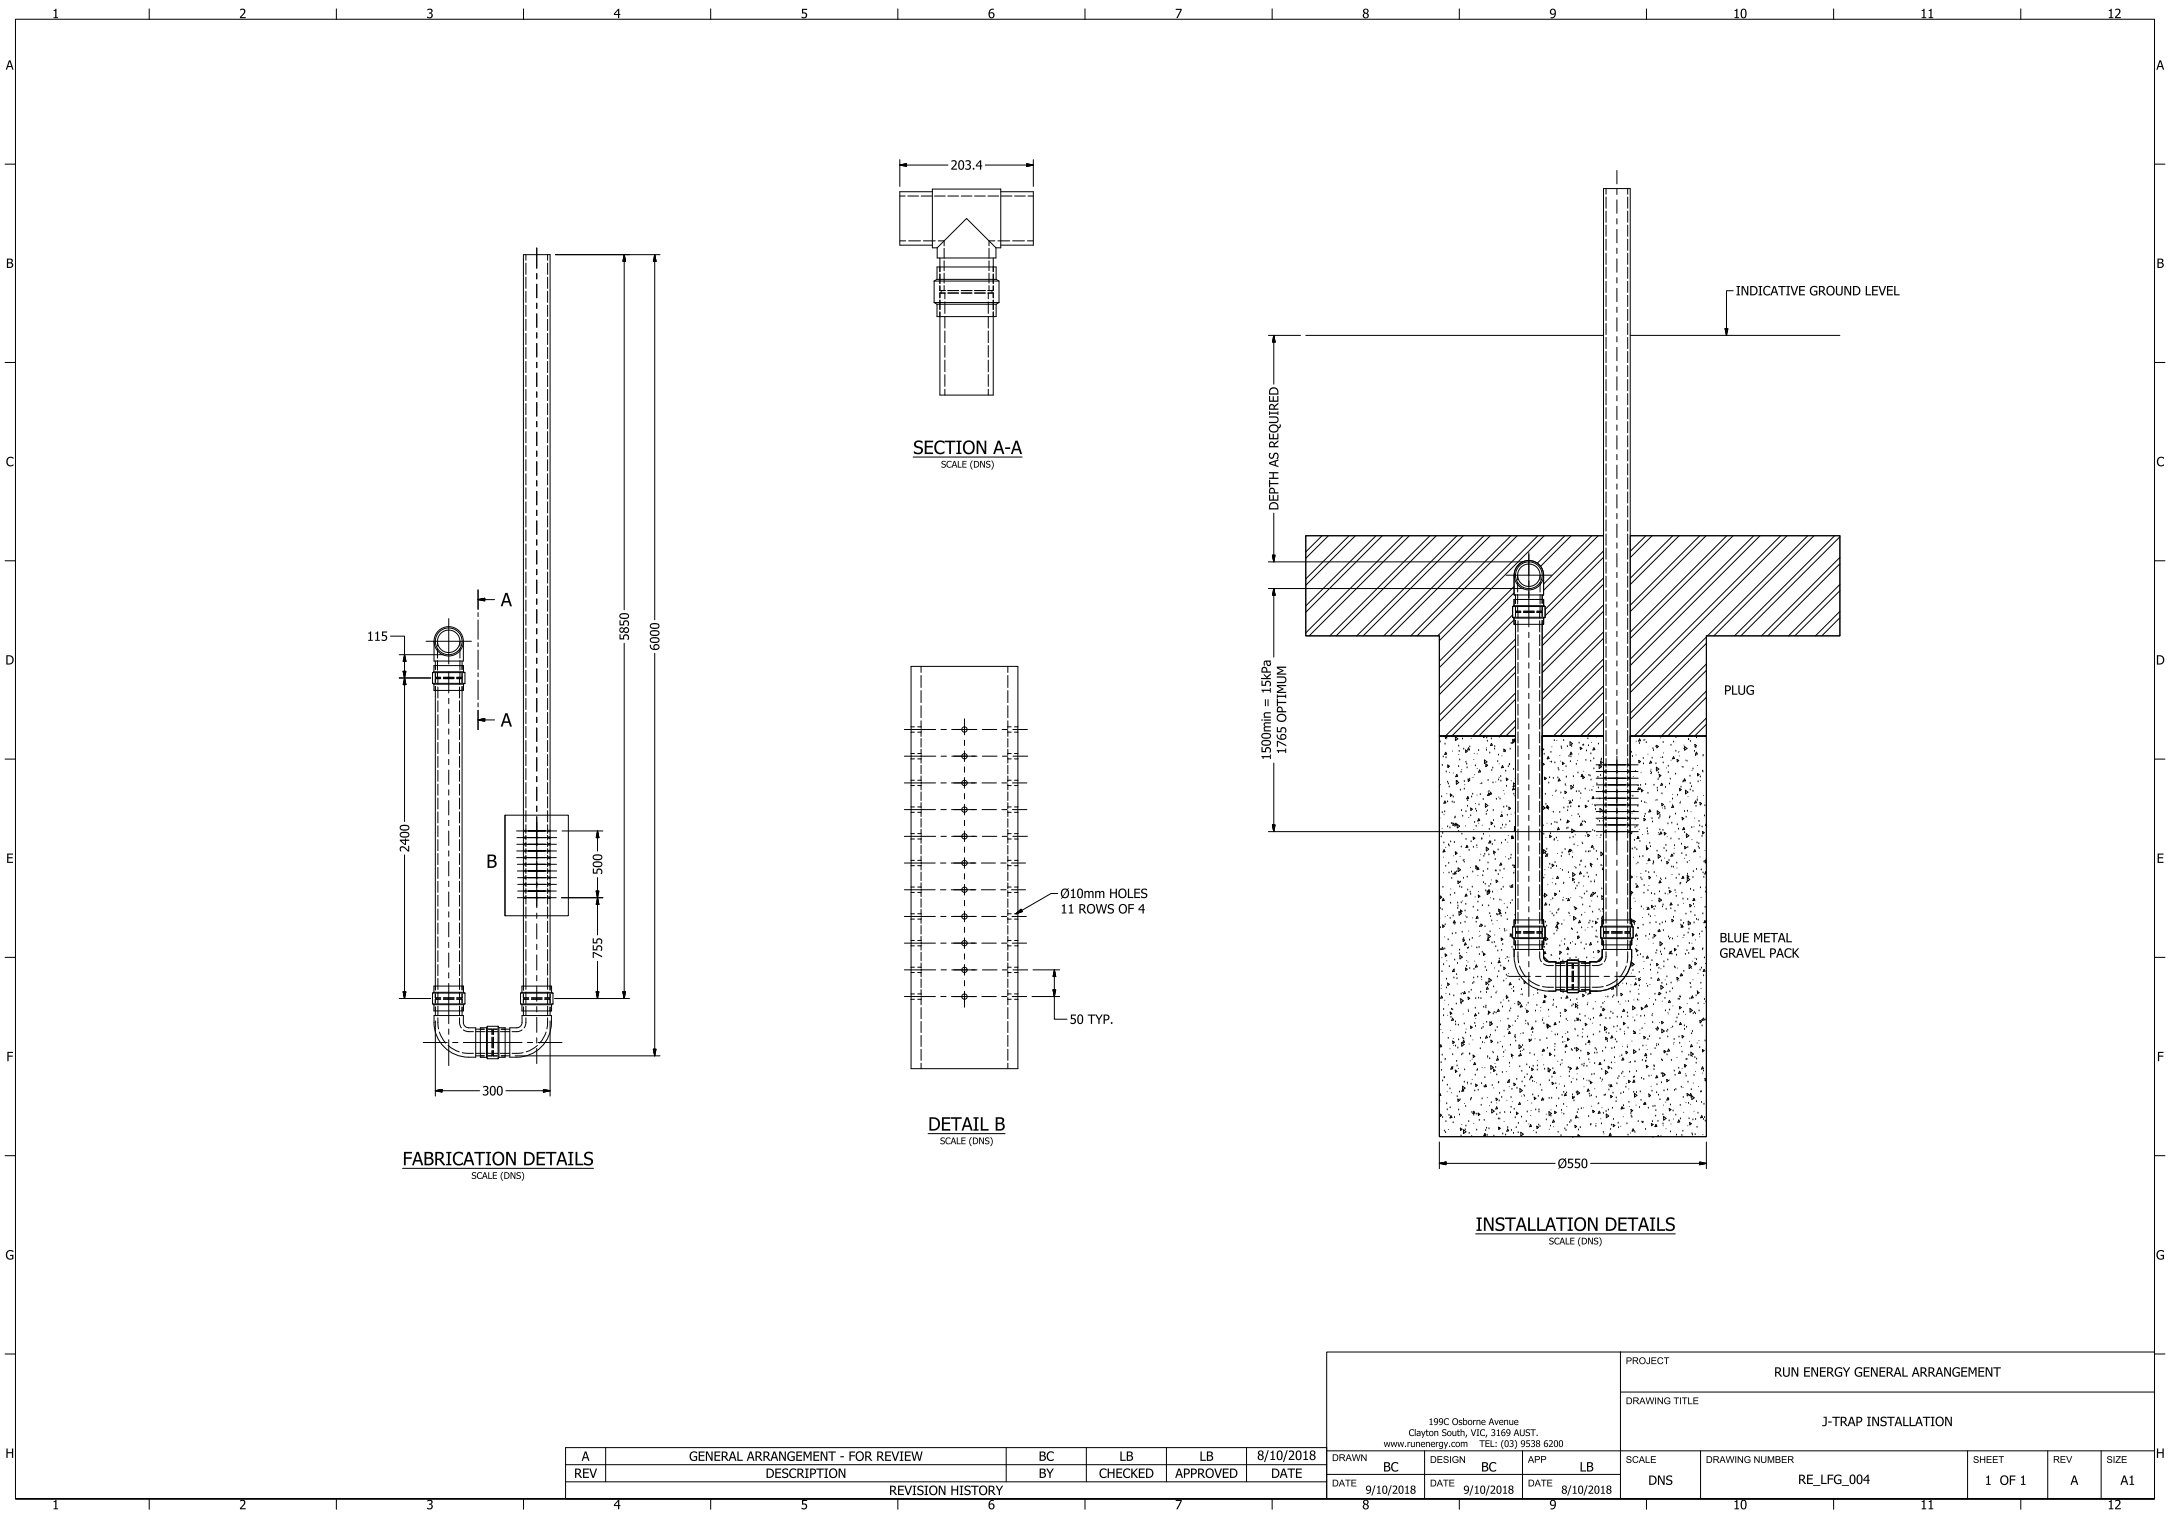

A	GENERAL ARRANGEMENT - FOR REVIEW	BC	LB	LB	8/10/2018
REV	DESCRIPTION	BY	CHECKED	APPROVED	DATE
REVISION HISTORY					


199C Osborne Avenue Clayton South, VIC, 3169 AUST. www.runenergy.com TEL: (03) 9538 6200	PROJECT RUN ENERGY GENERAL ARRANGEMENT					
	DRAWING TITLE J-TRAP INSTALLATION					
DRAWN BC	DESIGN BC	APP LB	SCALE DNS			DRAWING NUMBER RE_LFG_004
DATE 9/10/2018	DATE 9/10/2018	DATE 8/10/2018	SHEET 1 OF 1	REV A	SIZE A1	

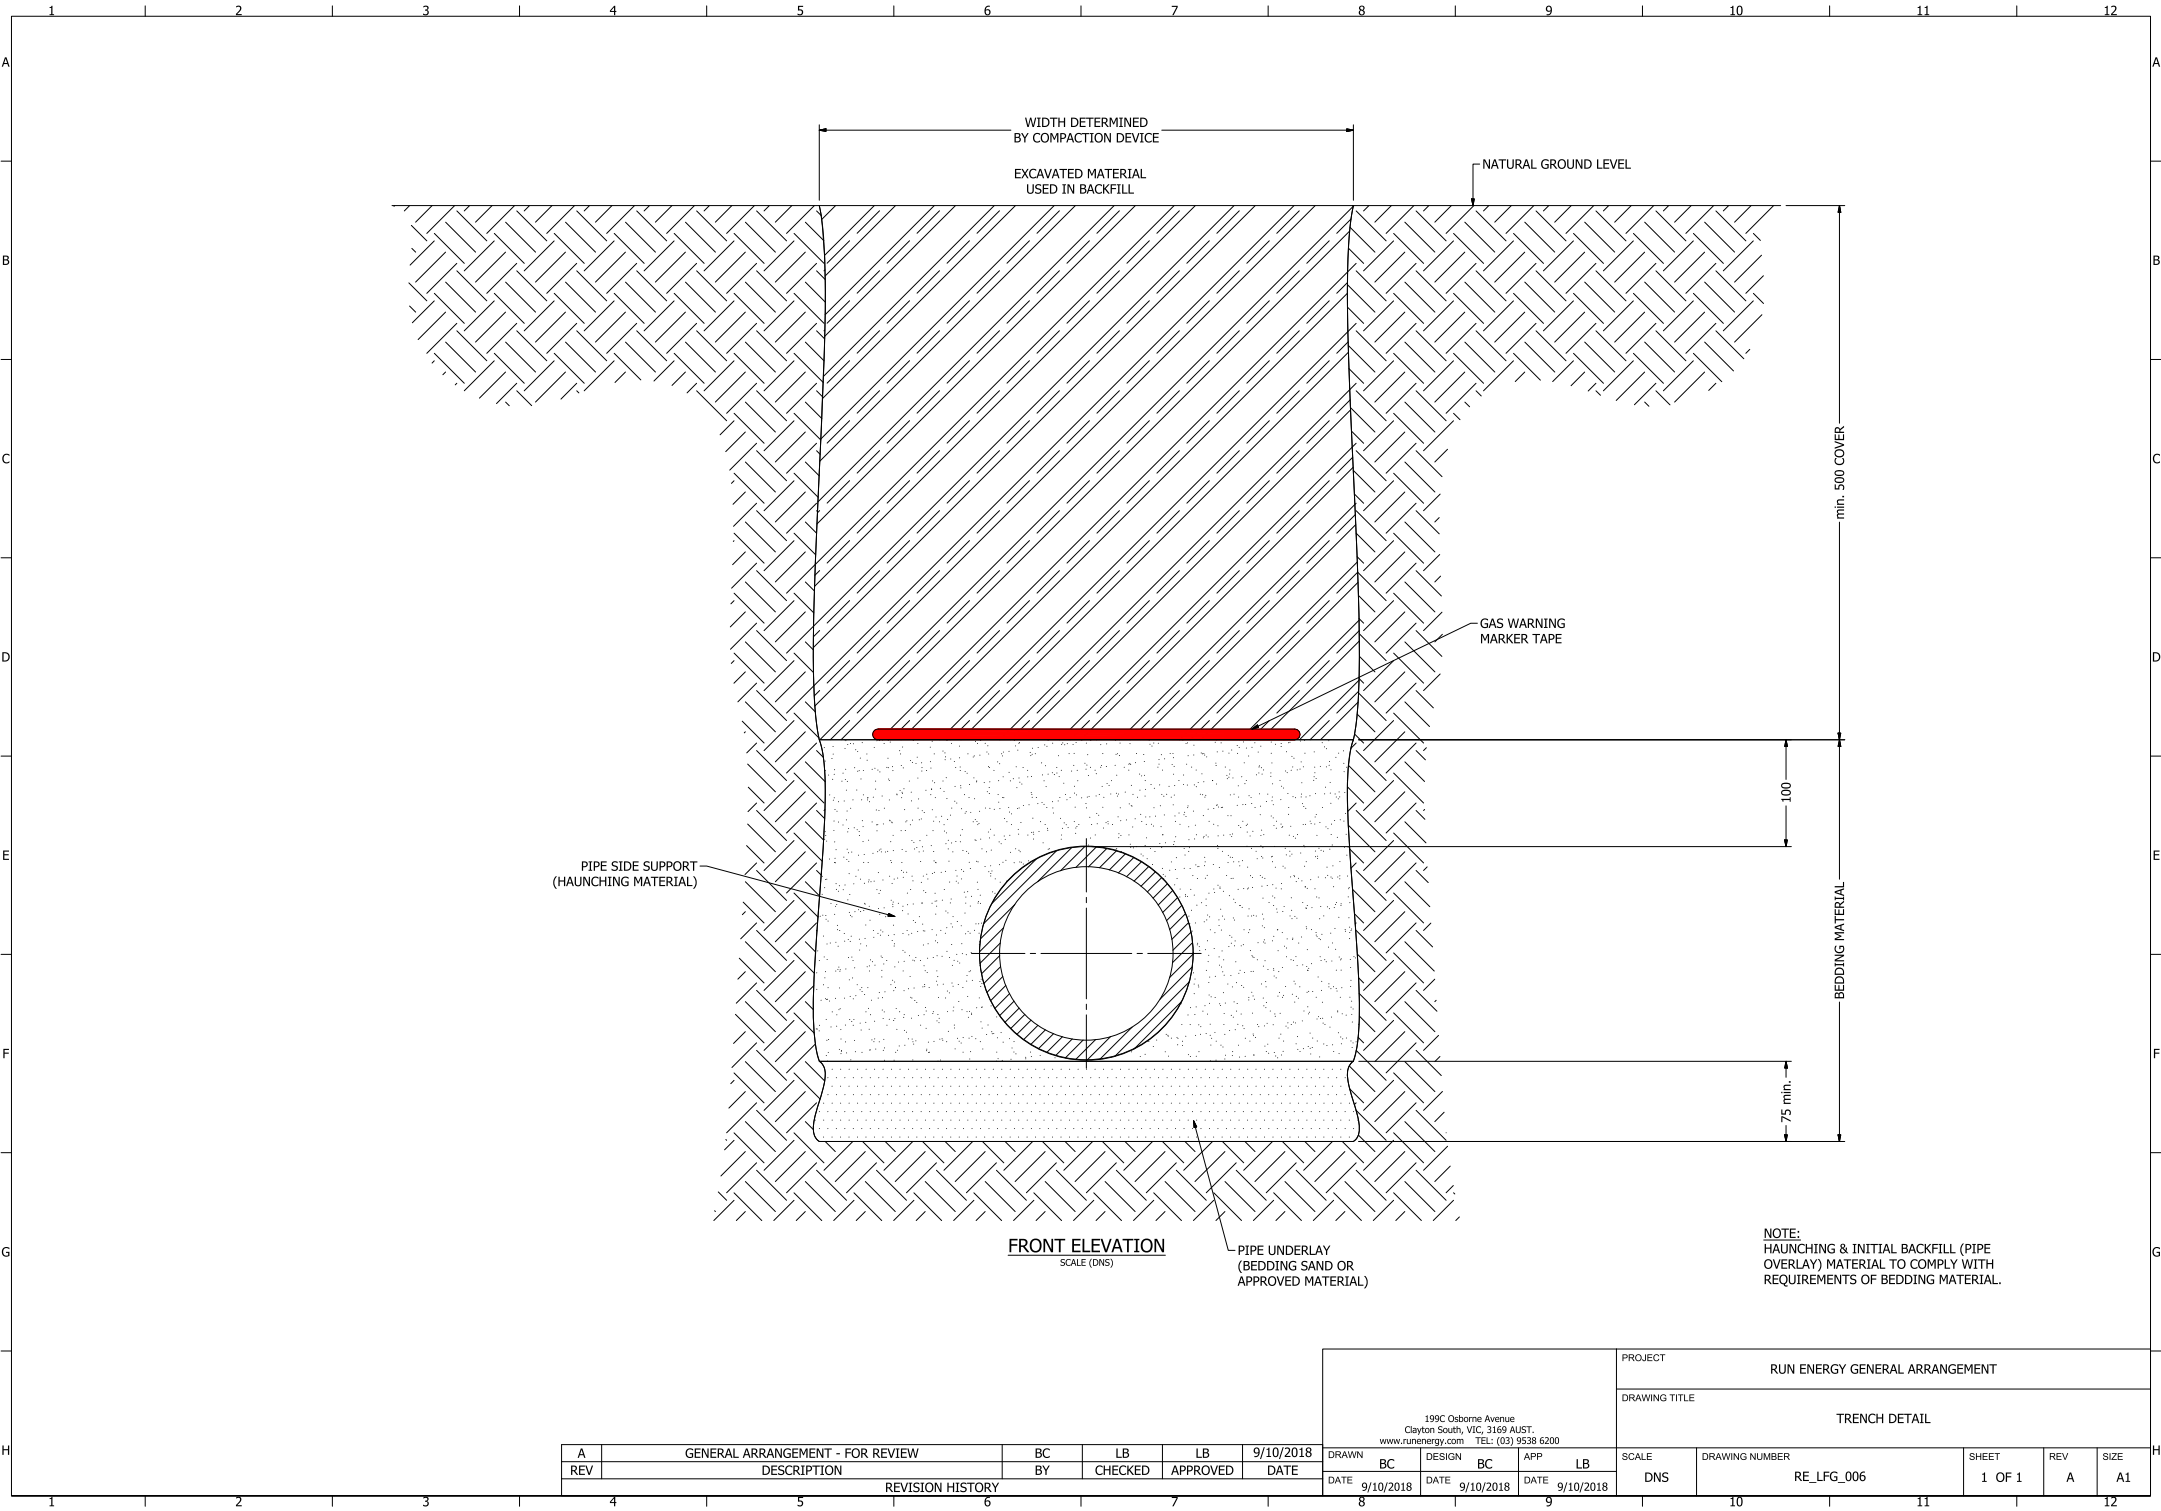

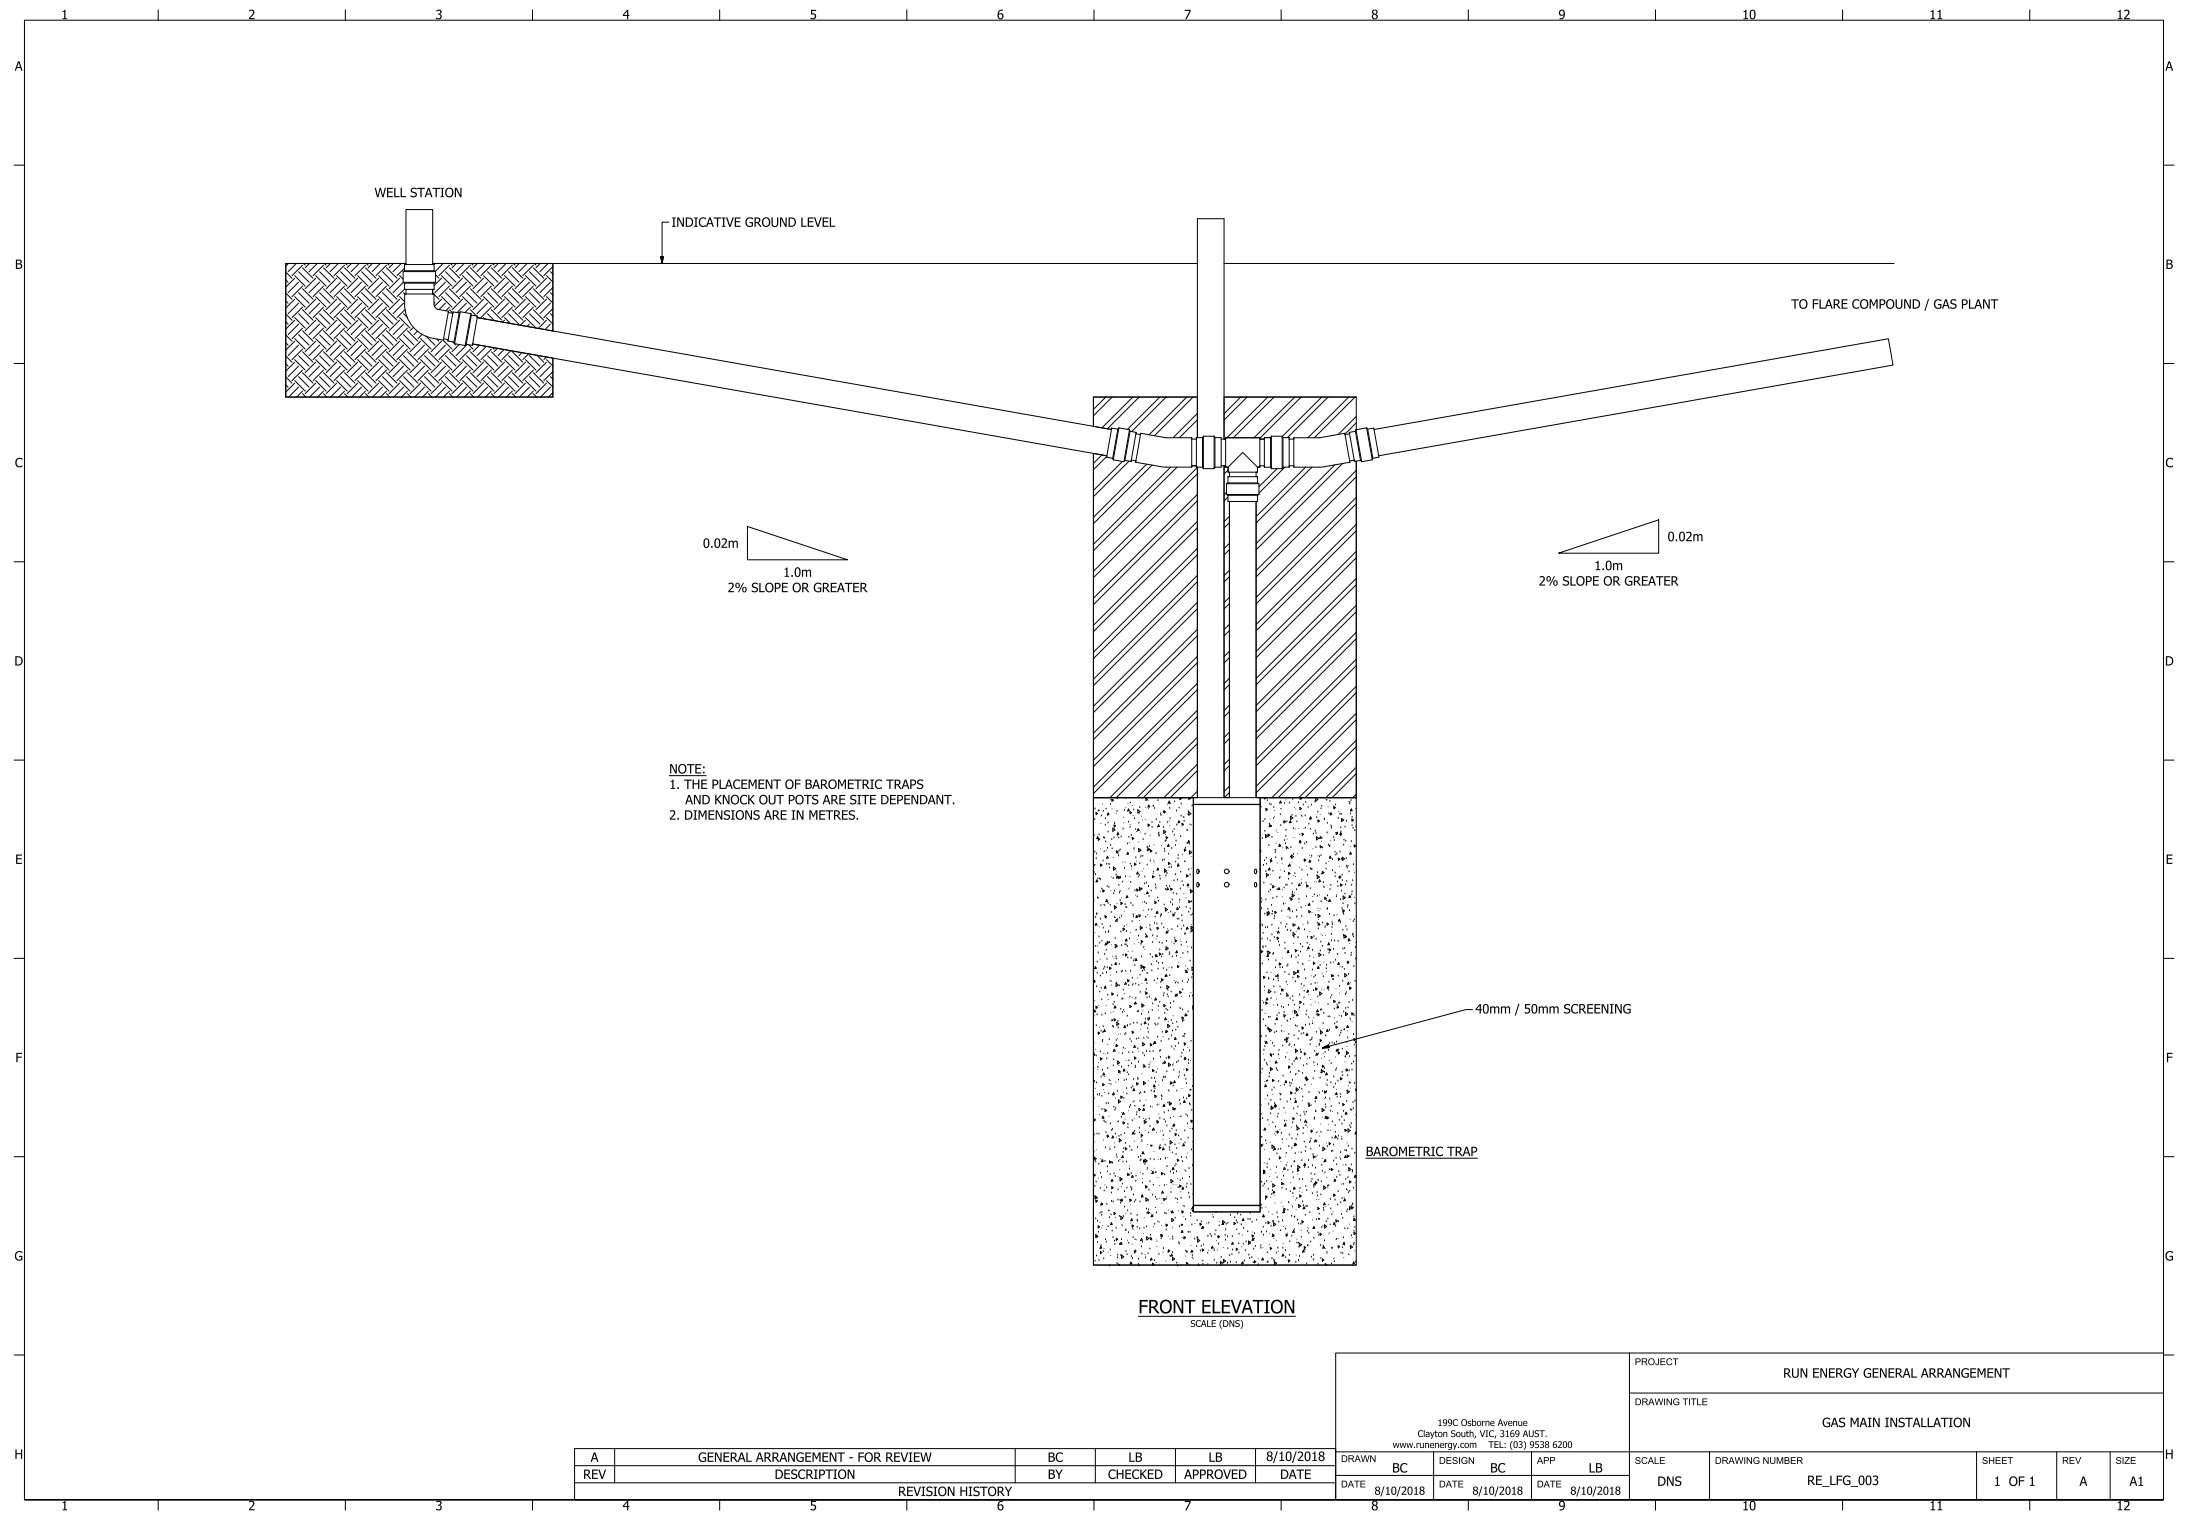

A	GENERAL ARRANGEMENT - FOR REVIEW	BC	LB	LB	8/10/2018
REV	DESCRIPTION	BY	CHECKED	APPROVED	DATE
REVISION HISTORY					

199C Osborne Avenue Clayton South, VIC, 3169 AUST. www.runenergy.com TEL: (03) 9538 6200						PROJECT						RUN ENERGY GENERAL ARRANGEMENT											
						DRAWING TITLE						GAS MAIN INSTALLATION											
DRAWN		BC		DESIGN		BC		APP		LB		SCALE		DRAWING NUMBER				SHEET		REV		SIZE	
DATE		8/10/2018		DATE		8/10/2018		DATE		8/10/2018		DNS		RE_LFG_003				1 OF 1		A		A1	

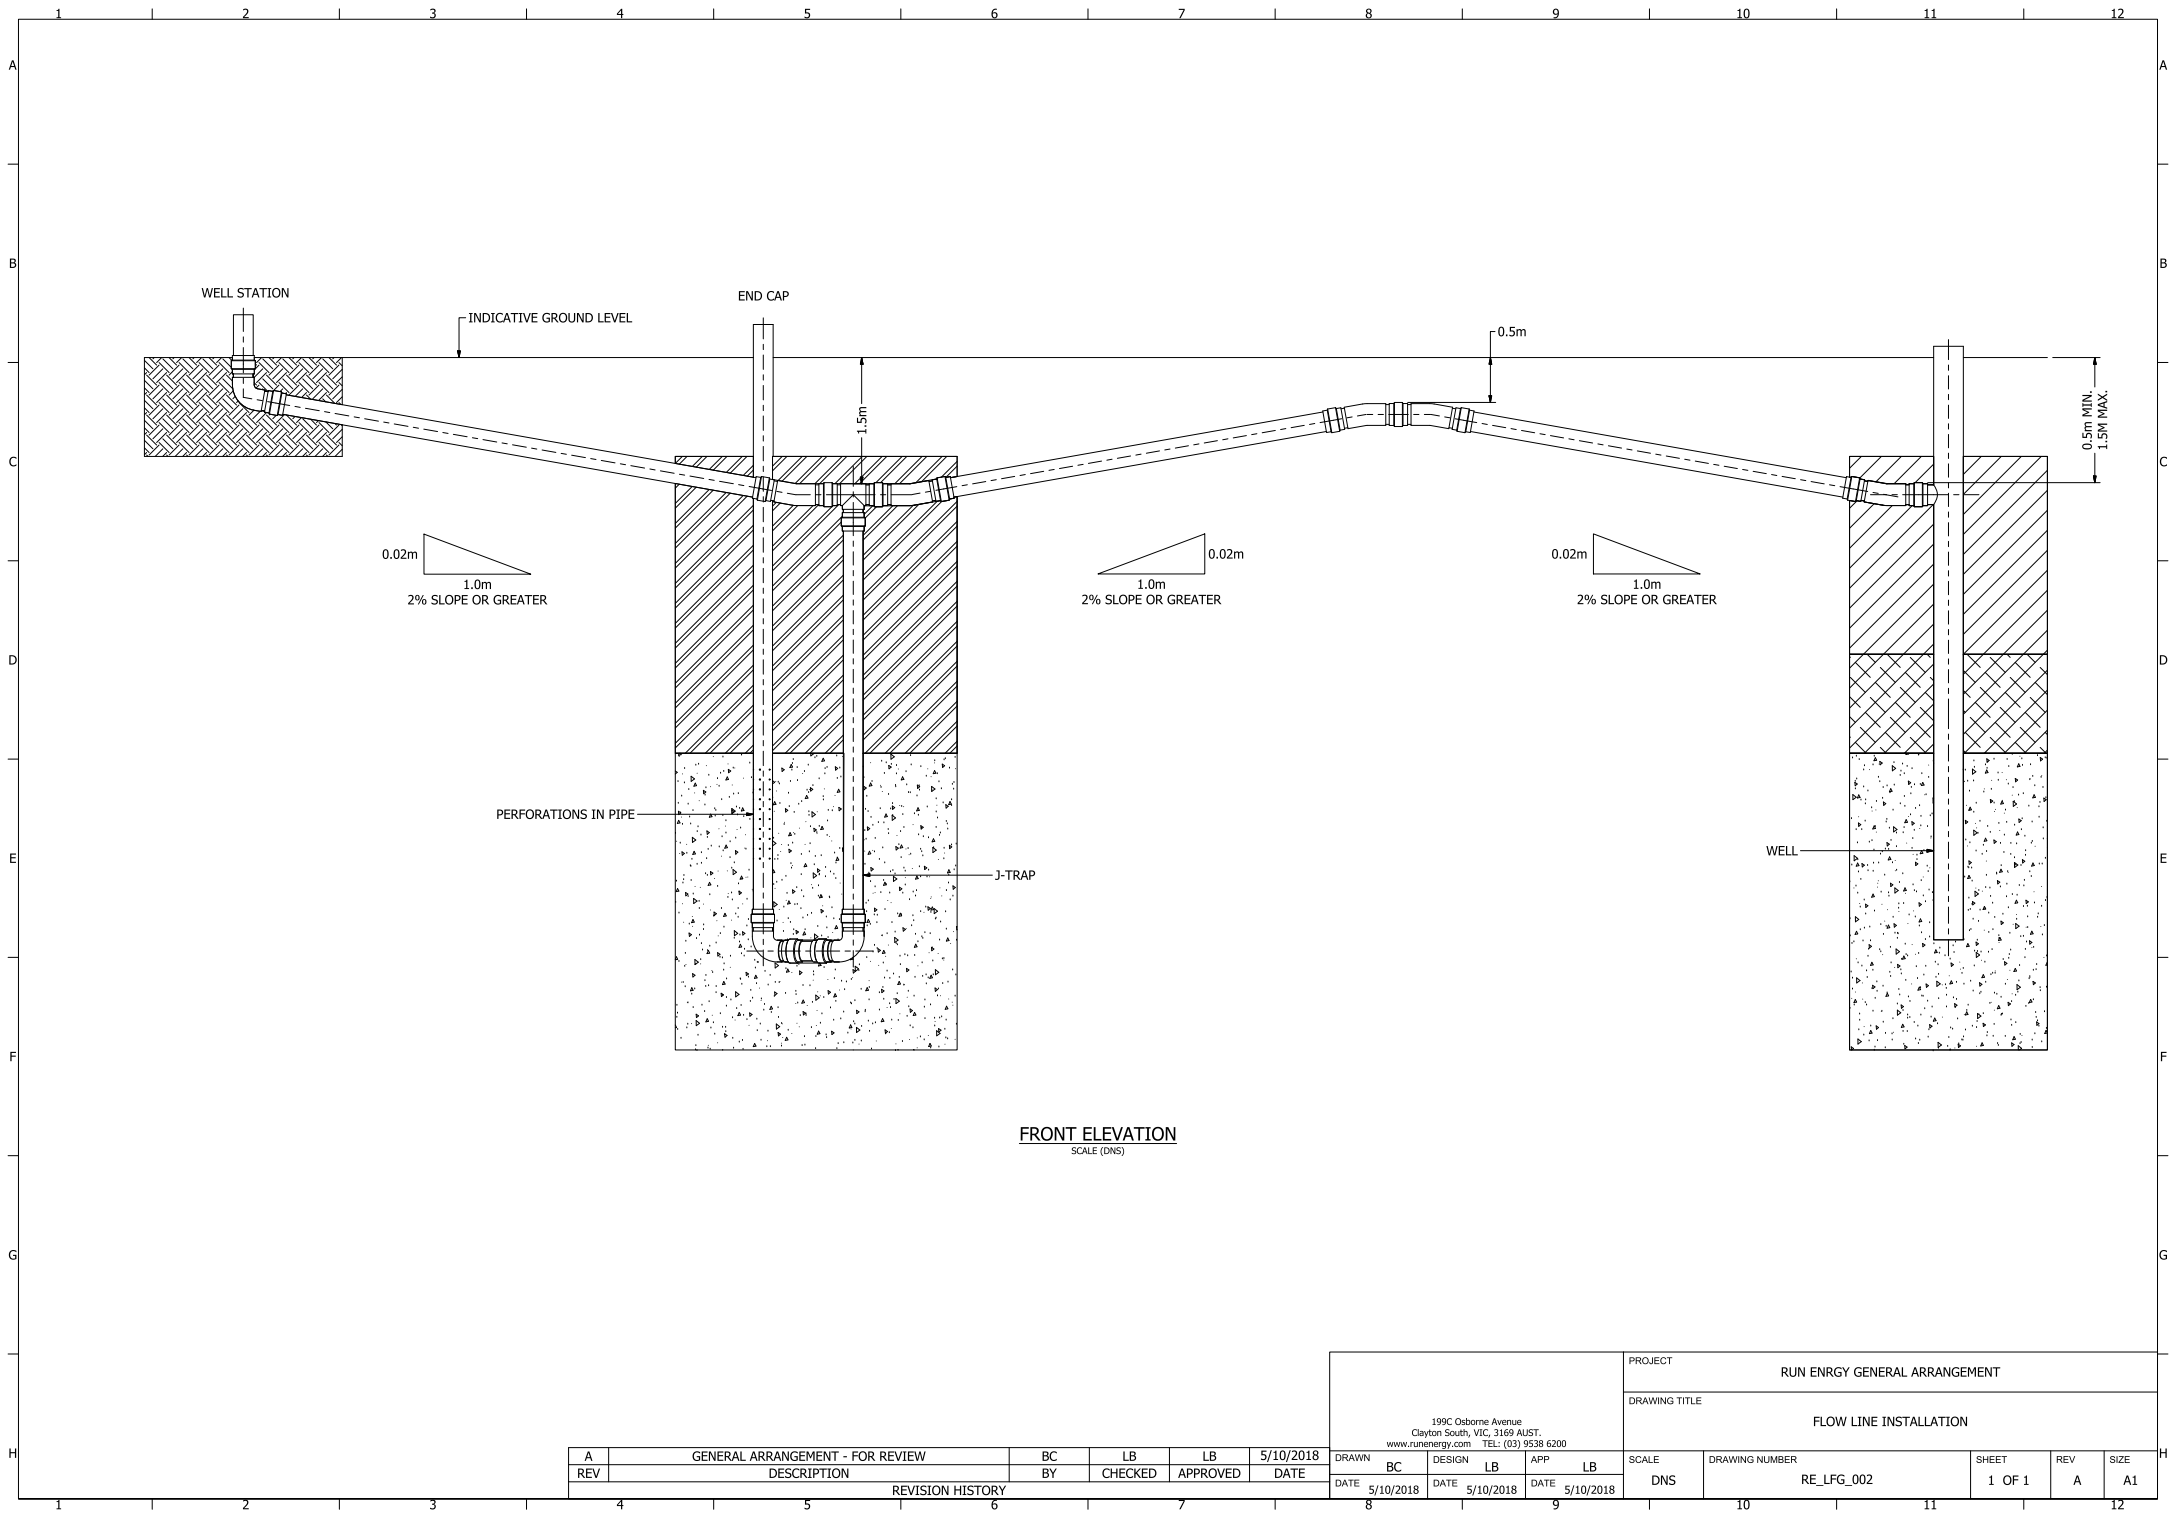

FRONT ELEVATION
SCALE (DNS)

A	GENERAL ARRANGEMENT - FOR REVIEW	BC	LB	LB	5/10/2018
REV	DESCRIPTION	BY	CHECKED	APPROVED	DATE
REVISION HISTORY					

199C Osborne Avenue Clayton South, VIC, 3169 AUST. www.runenergy.com TEL: (03) 9538 6200	PROJECT				
	RUN ENRGY GENERAL ARRANGEMENT				
	DRAWING TITLE				
	FLOW LINE INSTALLATION				
DRAWN	BC	DESIGN	LB	APP	LB
DATE	5/10/2018	DATE	5/10/2018	DATE	5/10/2018
SCALE		DRAWING NUMBER		SHEET	REV
DNS		RE_LFG_002		1 OF 1	A
				SIZE	A1