
 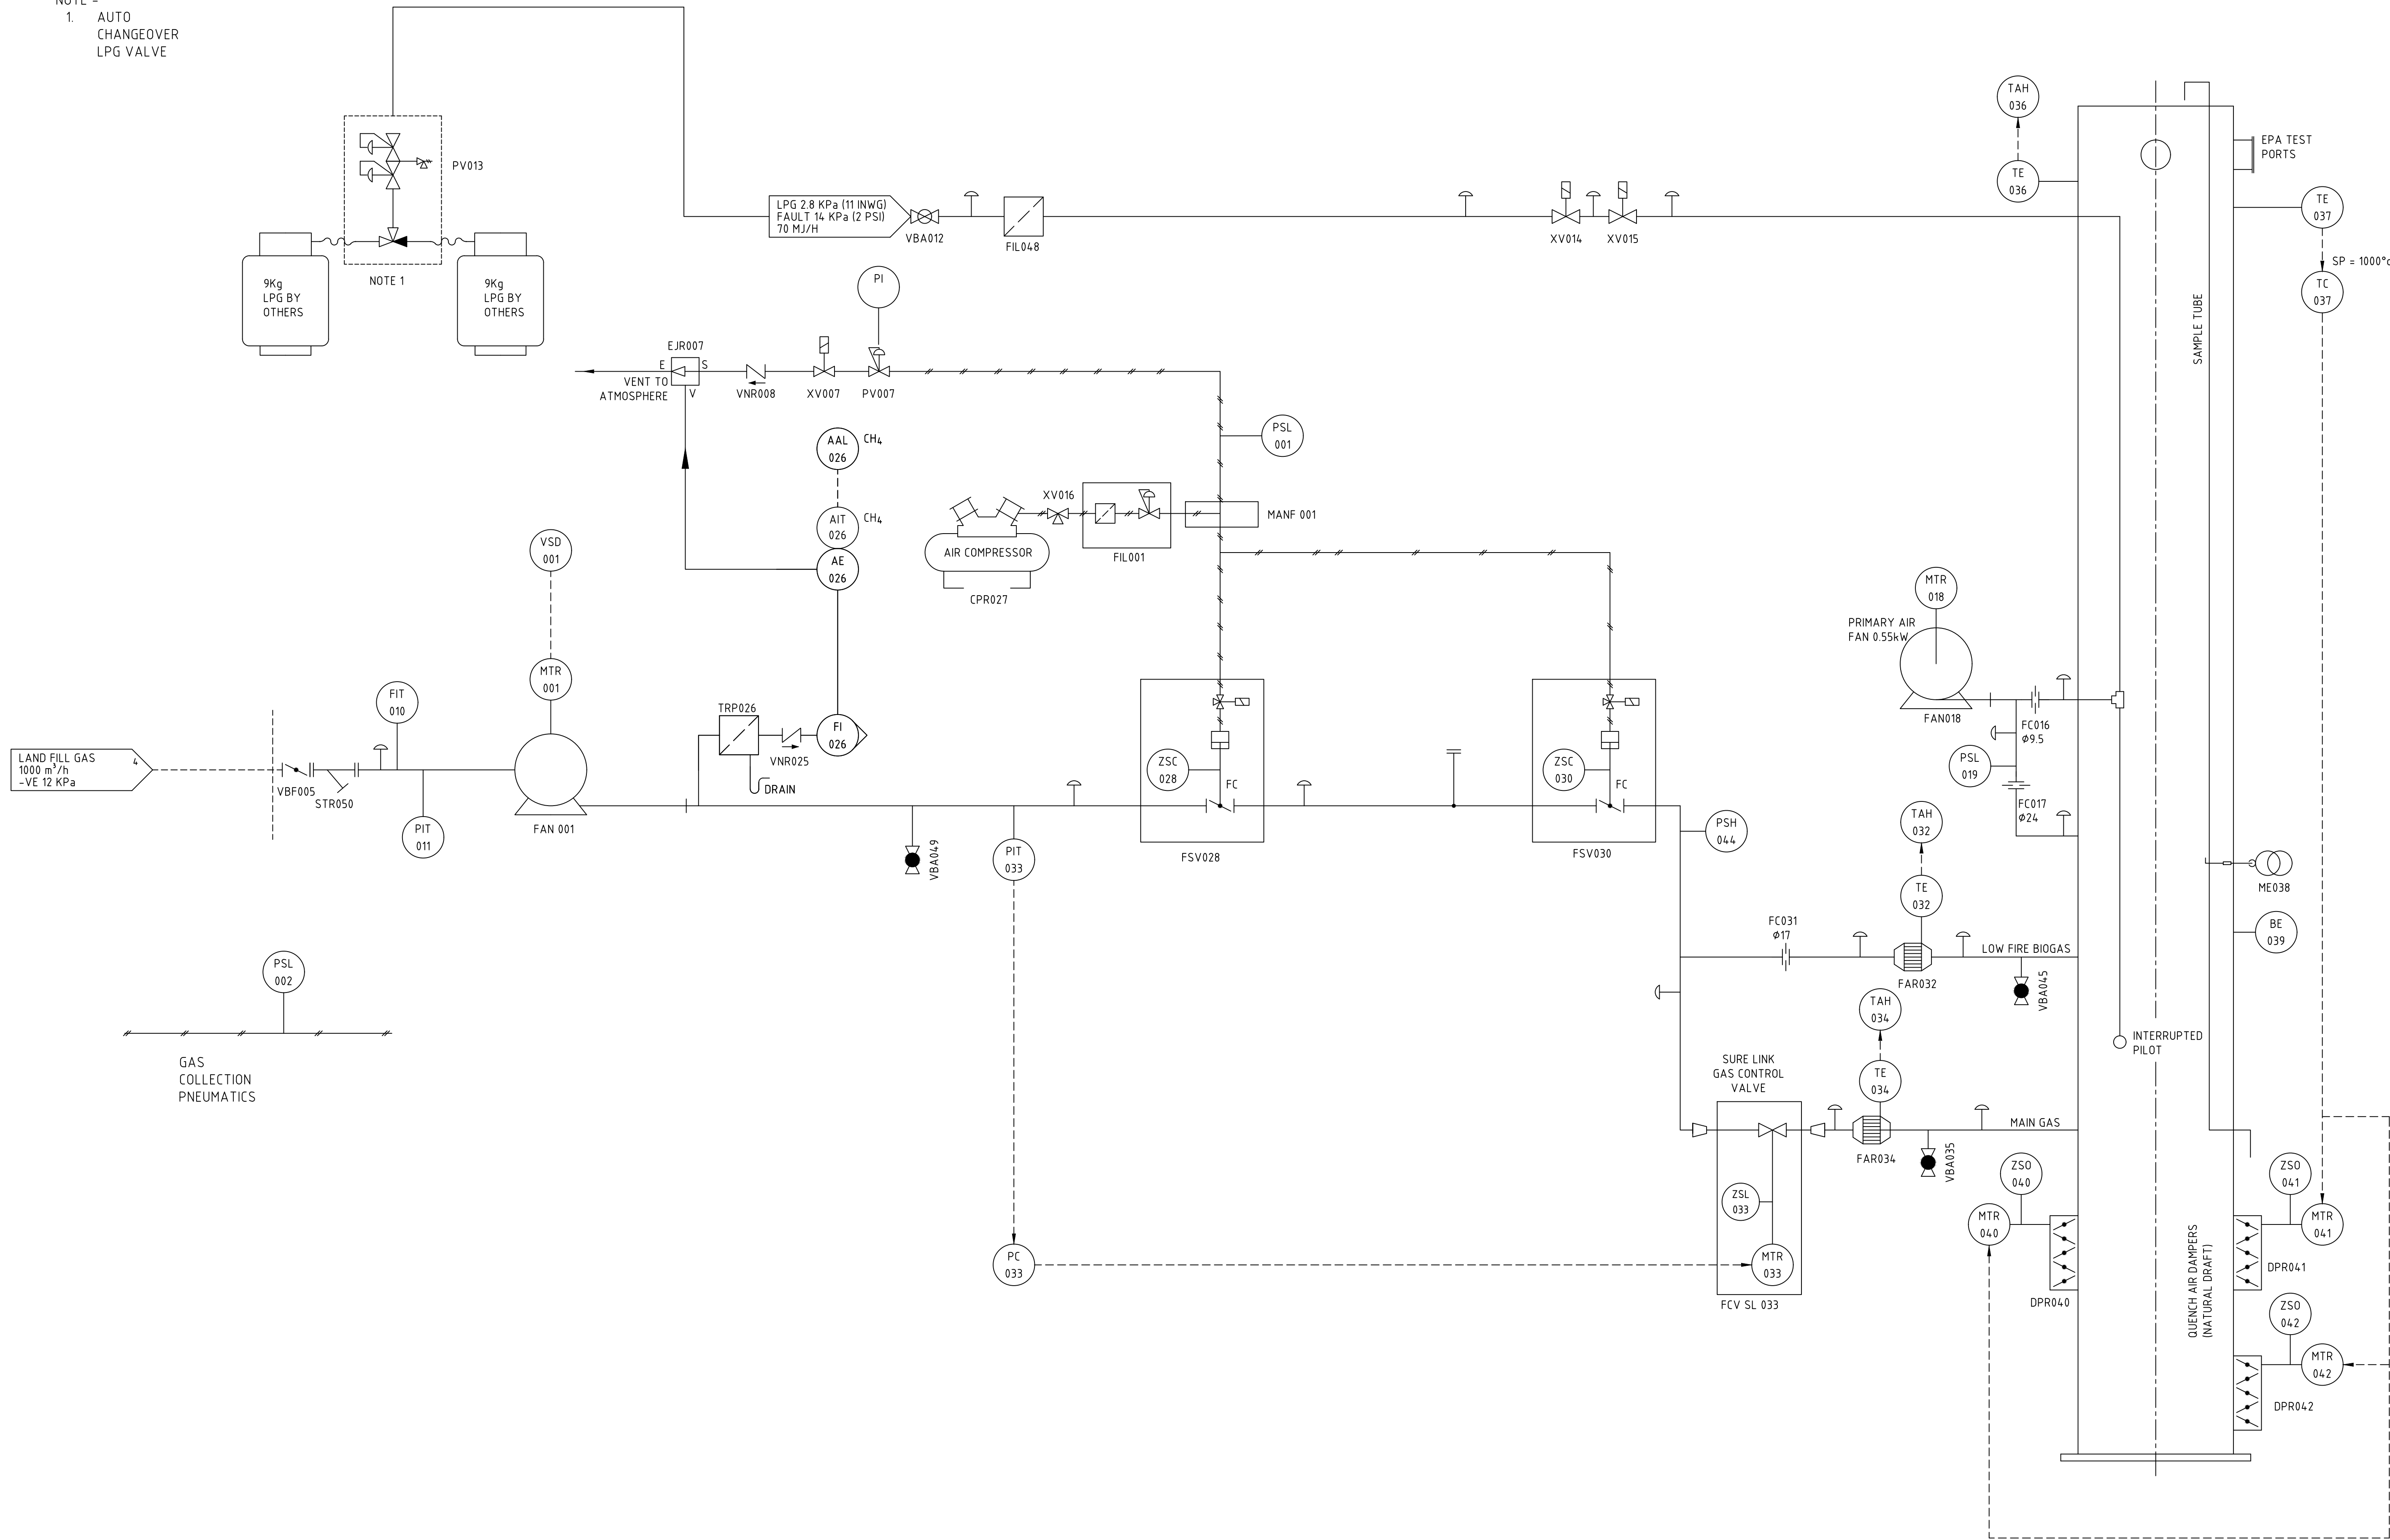


NOTE -
1. AUTO
CHANGEOVER
LPG VALVE



					1	UPDATE TAG DETAILS		CS	10/04/2017	THIS PRINT (OR DRAWING) REMAINS THE PROPERTY OF ABM COMBUSTION PTY. LTD. AND MUST BE RETURNED ON REQUEST. IT IS PROVIDED FOR USE ONLY WITH REFERENCE TO CONTRACTS ENTERED INTO, OR PROPOSALS MADE, BY ABM COMBUSTION PTY LTD. INFORMATION DISCLOSED BY THIS PRINT (OR DRAWING) IS THEREFORE, CONFIDENTIAL TO THE EXTENT TO WHICH IT IS NOT OTHERWISE PUBLICLY AVAILABLE, AND MUST NOT BE DISCLOSED TO OTHER PARTIES WITHOUT WRITTEN PERMISSION FROM ABM COMBUSTION PTY. LTD. THIS PRINT (OR DRAWING) MUST NOT BE COPIED, REPRODUCED, OR EXHIBITED TO OTHER PARTIES IN WHOLE OR IN PART WITHOUT WRITTEN PERMISSION FROM ABM COMBUSTION PTY. LTD.  ABM Combustion Pty Ltd 2/2 Access Way, Carrum Downs VIC 3201 Telephone +613 9770 8545 Facsimile +613 9770 8546 Email info@abmcombustion.com UNLESS NOTED OTHERWISE ALL FABRICATIONS SHALL COMPLY WITH THE DIMENSIONAL TOLERANCES SPECIFIED BELOW WHEN DIMENSIONS ARE IN mm. INDIVIDUAL COMPONENTS AND SUB-ASSEMBLIES SHALL BE FLAT, CONCENTRIC, SQUARE & PARALLEL WITHIN THE SAME TOLERANCES AS APPLICABLE TO PREVENT COMPOUNDING.<table><tr><td>MACHINING: UP TO 50mm ±0.1 51 TO 100mm ±0.2 101 - 300mm ±0.4 301 - 1000mm ±0.8 OVER 1001mm ±1.0</td><td>FABRICATION: UP TO 300mm ±1 301 - 1000mm ±1.5 1001 - 3000mm ±2 3001 - 5000mm ±2.5 OVER 5001mm ±3</td><td>ANGULAR: ±0.25 WHEN NOT OVERRIDDEN BY LINEAR TOLERANCES</td></tr></table>	MACHINING: UP TO 50mm ±0.1 51 TO 100mm ±0.2 101 - 300mm ±0.4 301 - 1000mm ±0.8 OVER 1001mm ±1.0	FABRICATION: UP TO 300mm ±1 301 - 1000mm ±1.5 1001 - 3000mm ±2 3001 - 5000mm ±2.5 OVER 5001mm ±3	ANGULAR: ±0.25 WHEN NOT OVERRIDDEN BY LINEAR TOLERANCES
MACHINING: UP TO 50mm ±0.1 51 TO 100mm ±0.2 101 - 300mm ±0.4 301 - 1000mm ±0.8 OVER 1001mm ±1.0	FABRICATION: UP TO 300mm ±1 301 - 1000mm ±1.5 1001 - 3000mm ±2 3001 - 5000mm ±2.5 OVER 5001mm ±3	ANGULAR: ±0.25 WHEN NOT OVERRIDDEN BY LINEAR TOLERANCES											
					0	ISSUE FOR CONSTRUCTION		CS	20/03/2017				
					B	TEST POINT ADDED DOWNSTREAM OF XX050		GK	21/12/2016				
					A	ISSUED FOR REVIEW		AL	30/11/2016				
2	AS BUILT / COMMISSIONED	CS	08/08/2017		REV	REVISION	DRN	DATE	CKD				
REV	REVISION	DRN	DATE	CKD	REV	REVISION	DRN	DATE	CKD				

THIRD ANGLE	DRAWN	AL	TITLE
	CKD	APPR	RUN ENERGY - TAMWORTH, NSW OEF 100 LANDFILL BIOGAS FLARE P&ID
PROJECTION	DATE	30/11/2016	DRAWING No
SHEET SIZE A1	SCALE	NTS	J4315-PID-1000
-	JOB No	04315	REVISION
			2